


LUMINAIRE SCHEDULE / ATODLEN UNEDAU GOLEUO	
	LUMINAIRE REF / UNED OLEUO CYF- A MANUFACTURER / GWNEUTHURWR- THORLUX MODEL / MODEL- REALTA (WALL MOUNTED) SPECIFICATION / MANYLION- 8W, 3000K, POLYCARBONATE COVER, WIDE DISTRIBUTION, SMART, EMERGENCY.
	LUMINAIRE REF / UNED OLEUO CYF- A MANUFACTURER / GWNEUTHURWR- THORLUX MODEL / MODEL- REALTA (COLUMN MOUNTED 4m) SPECIFICATION / MANYLION- 8W, 3000K, POLYCARBONATE COVER, WIDE DISTRIBUTION, SMART.
	LUMINAIRE REF UNED OLEUO CYF- C MANUFACTURER / GWNEUTHURWR- THORLUX MODEL / MODEL- STARBEAM SPECIFICATION / MANYLION- 31W, 3000K, AREA DISTRIBUTION, SMART.
	SINGLE HEAD COLUMN MOUNTED LUMINAIRE / UNED OLEUO COLOFN UNIGOL "X" DENOTES LUMINAIRE REFERENCE / CYFEIRNOD UNED OLEUO "Nm" DENOTES COLUMN HEIGHT / UCHDER UNED OLEUO
	TWIN HEAD COLUMN MOUNTED LUMINAIRE / UNED OLEUO COLOFN GEFEILLIO "X" DENOTES LUMINAIRE REFERENCE / CYFEIRNOD UNED OLEUO "Nm" DENOTES COLUMN HEIGHT / UCHDER UNED OLEUO
	WALL MOUNTED LUMINAIRE / UNED OLEUO WAL "X" DENOTES LUMINAIRE REFERENCE / CYFEIRNOD UNED OLEUO

ISOLINES

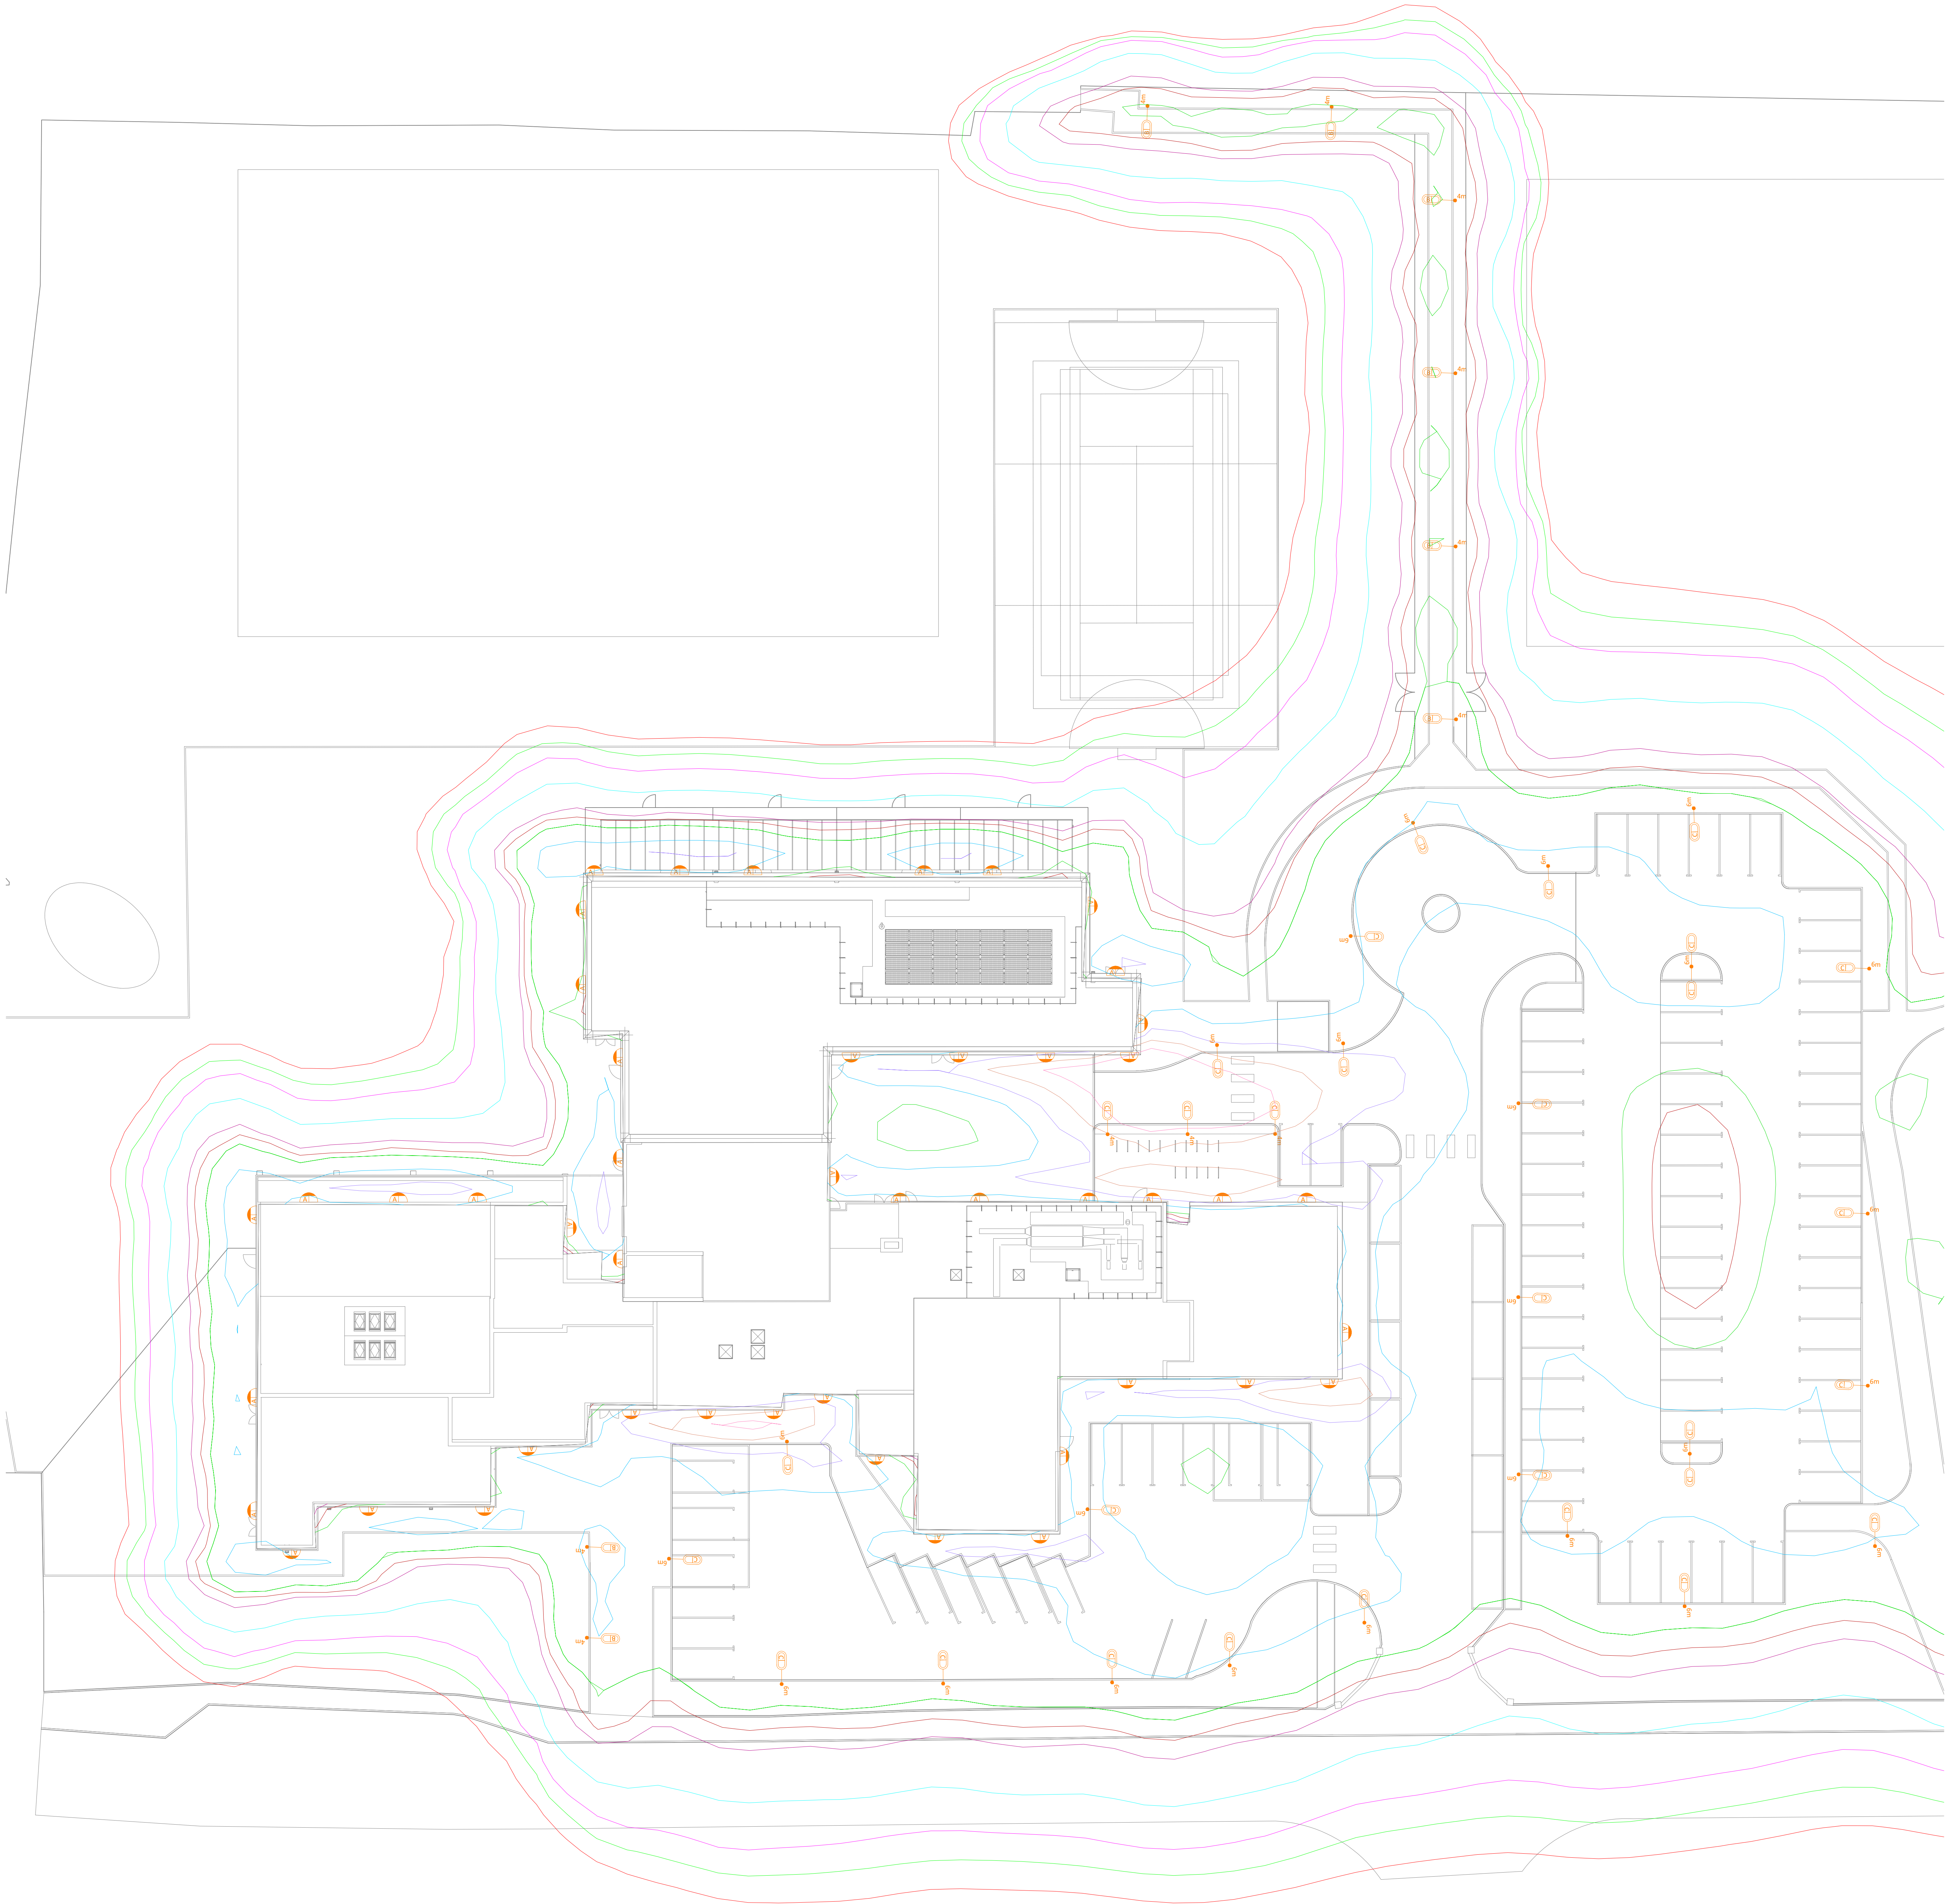

Status	Purpose of Issue
S2	

Client




Project

YSGOL GYNRADD GYMUNEDOL PARC BORRAS / BORRAS CP SCHOOL

Drawing Title

CYNLLUN GOLEUO ALLANOL /
EXTERNAL LIGHTING LAYOUT
CYNLLUN 1 OR 2 / SHEET 1 OF 2

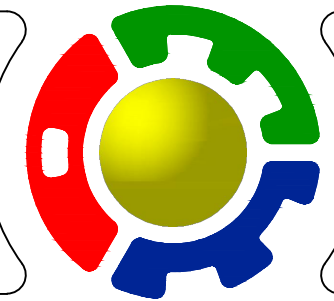

DAVIES PARTNERSHIP
BUILDING SERVICES CONSULTING ENGINEERS
ENVIRONMENTAL | DYNAMIC MODELLING | SUSTAINABLE DESIGN

Cestrian House, Lightfoot Street, Hoole, Chester, CH2 3AD.
Tel: 01244 315568
Email - cad@daviespartnership.co.uk
www.daviespartnership.co.uk



Date	10/05/20	Scale	1:200 @ A0	Eng	MR
Drw. No.	BOR-DPL-A0-XX-DR-E-0003	CAD		Rev.	P03